

REMOVABLE GRP ROOF

ROOF TO HAVE EXPLOSION RELIEF FITTINGS

EAVES VENTILATION TO BE PROVIDED TO 3 SIDES (REAR & SIDES)

2400 room ht

LOCKING COVER

FRONT ELEVATION

REAR ELEVATION

SIDE ELEVATION

SUBSTATION DOORS TO MEET SPECIFICATION WITH VENTILATION OPENINGS, IN 2590x2400mm HIGH BRICKWORK OPENING

2m WIDE CLEAR ACCESS AROUND SUBSTATION FOR MAINTENANCE

3900 (Internal)

26.2m<sup>3</sup>

2800 (Internal)


GENERATOR CABLE ACCESS PLATE

ELECTRICAL LAYOUT

CONSTRUCTION DRAWING

50 x 160mm REBATE TO ACCEPT PREFABRICATED ENCLOSURES

SECTION A-A

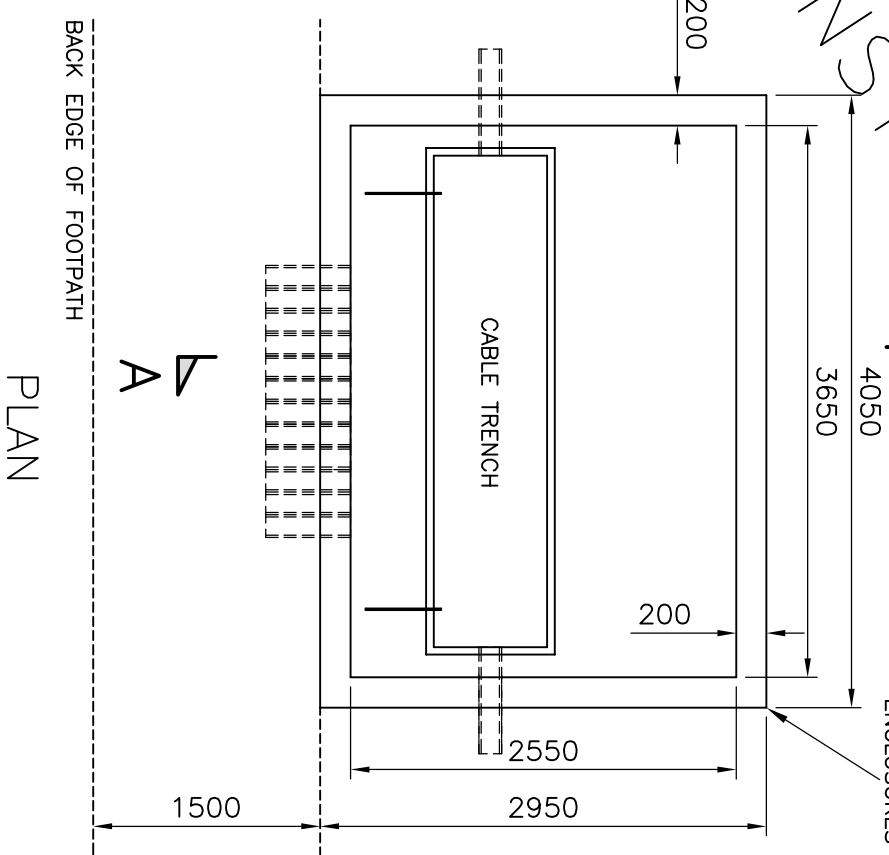

PLAN



Manufacturer Details

Sheet No. 1 Scale AS SHOWN

Prepared By TD

Revised Grid Reference

Date Issued 14.11.11

Checked By CD

Lloyds Court, 78 Grey Street, Newcastle Upon Tyne, NE1 6AF

800 - 1000kVA UDE PREFABRICATED ENCLOSURE

Document Details

GENERAL ARRANGEMENT / PLAN & ELEVATIONS

Ref No. C993892

Revision A

Notes